




VENDOR DRAWING #: TM 2.71.08-2 SH3

VENDOR NAME: CCE

CADD Drawing. DO NOT REVISE MANUALLY.

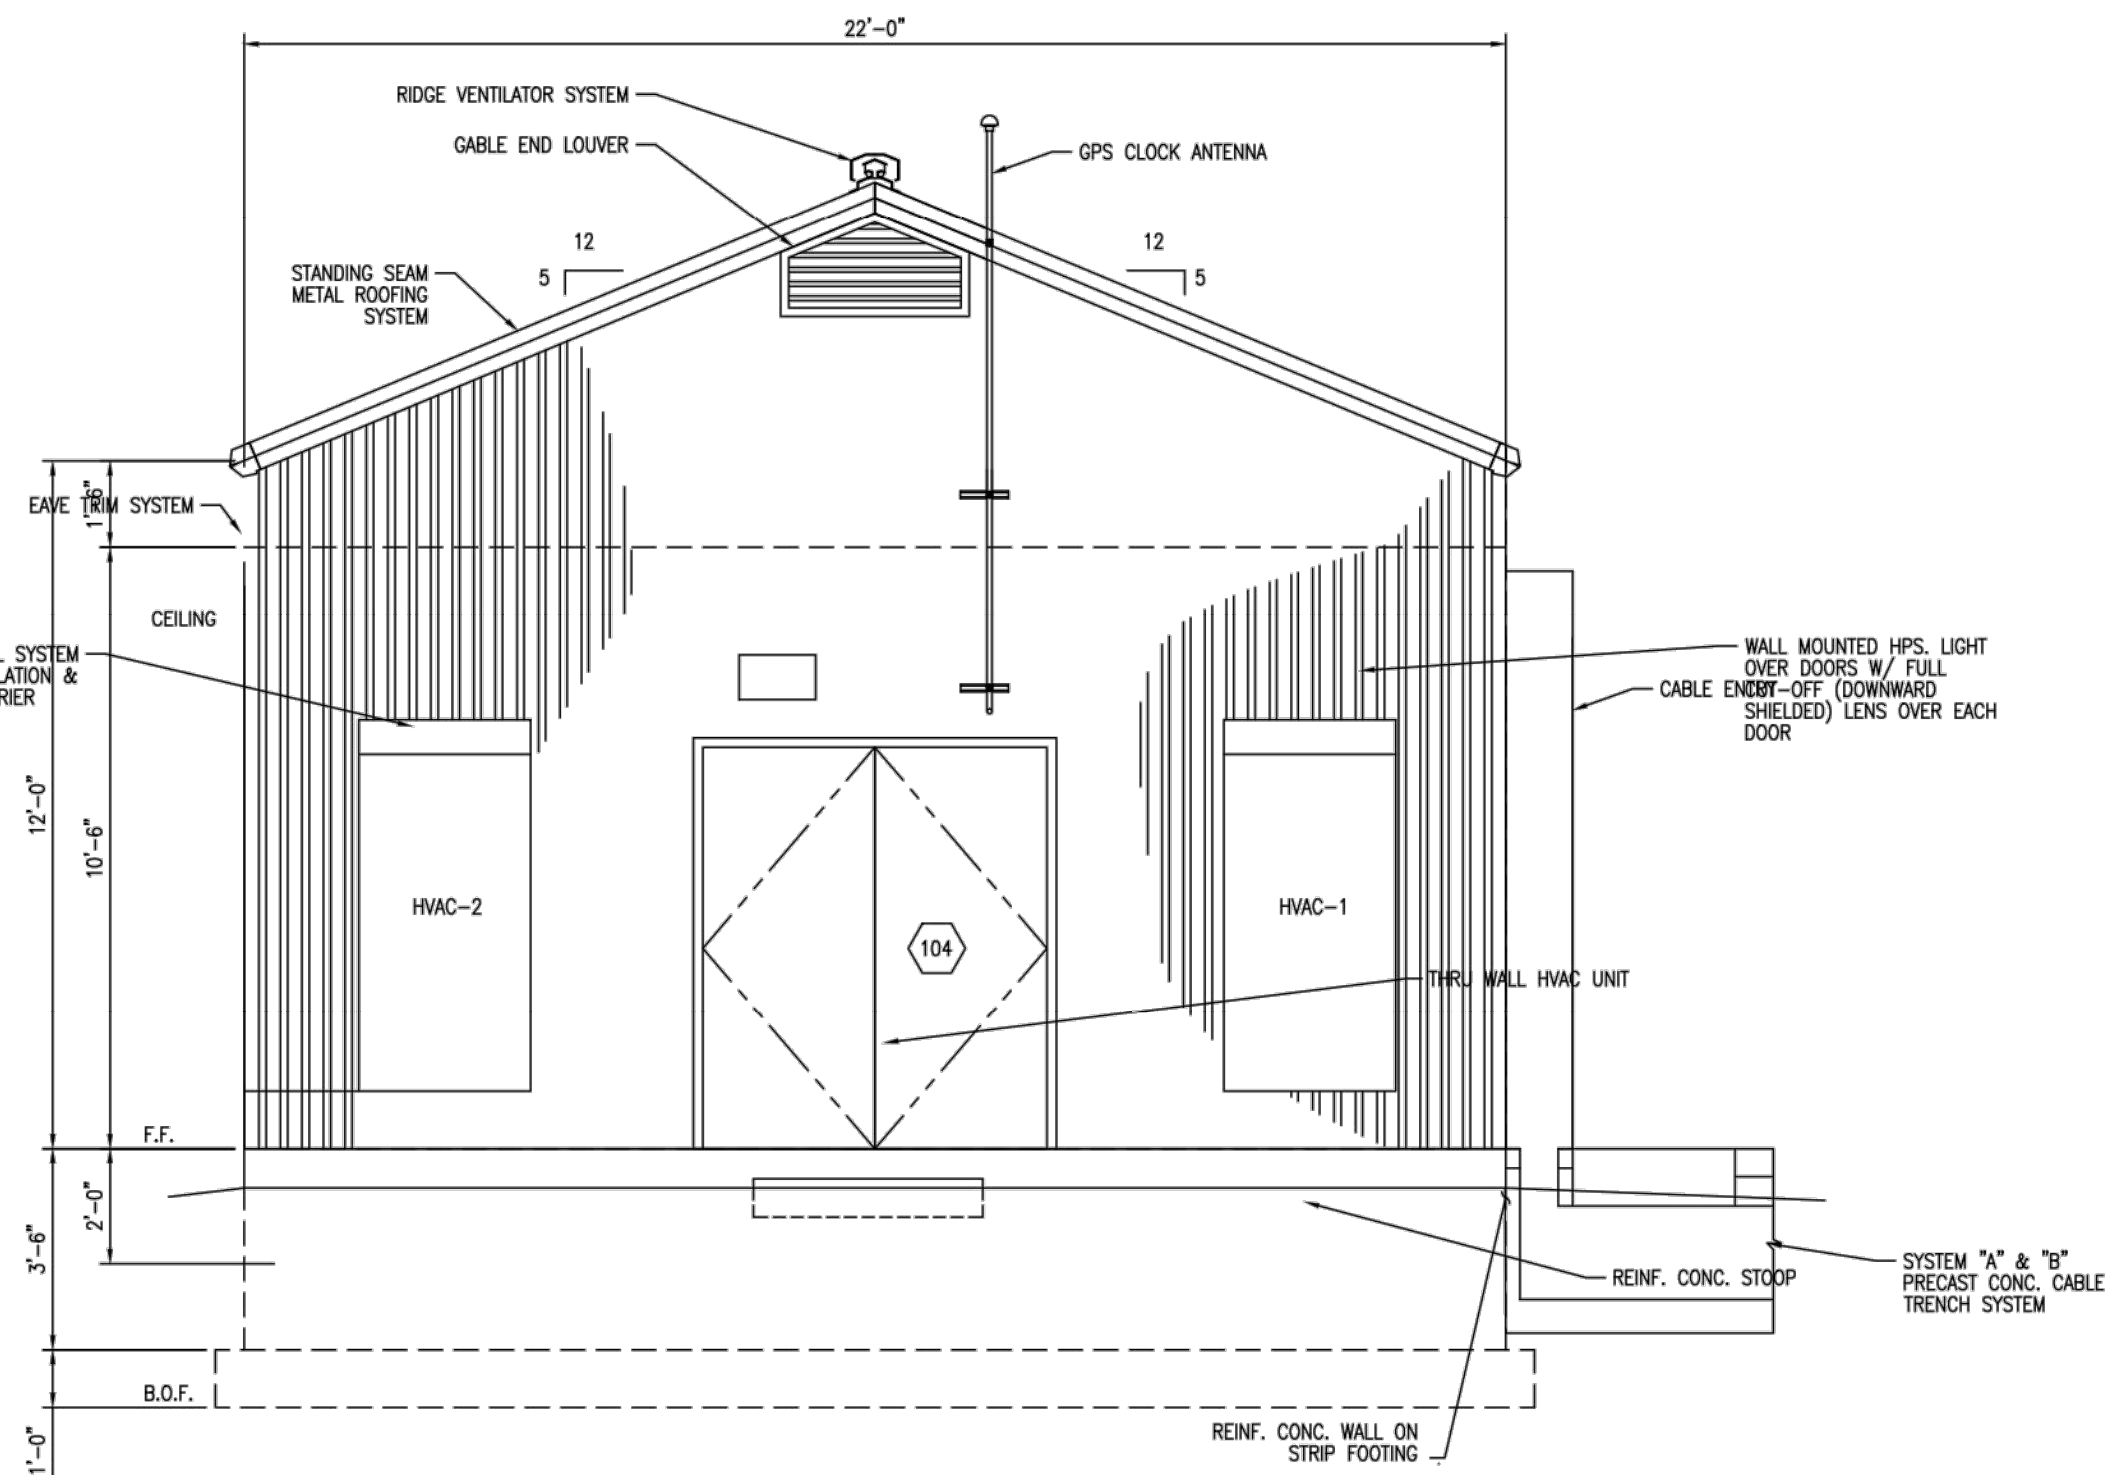


**EAST ELEVATION**  
SCALE: 1/4"=1'-0"

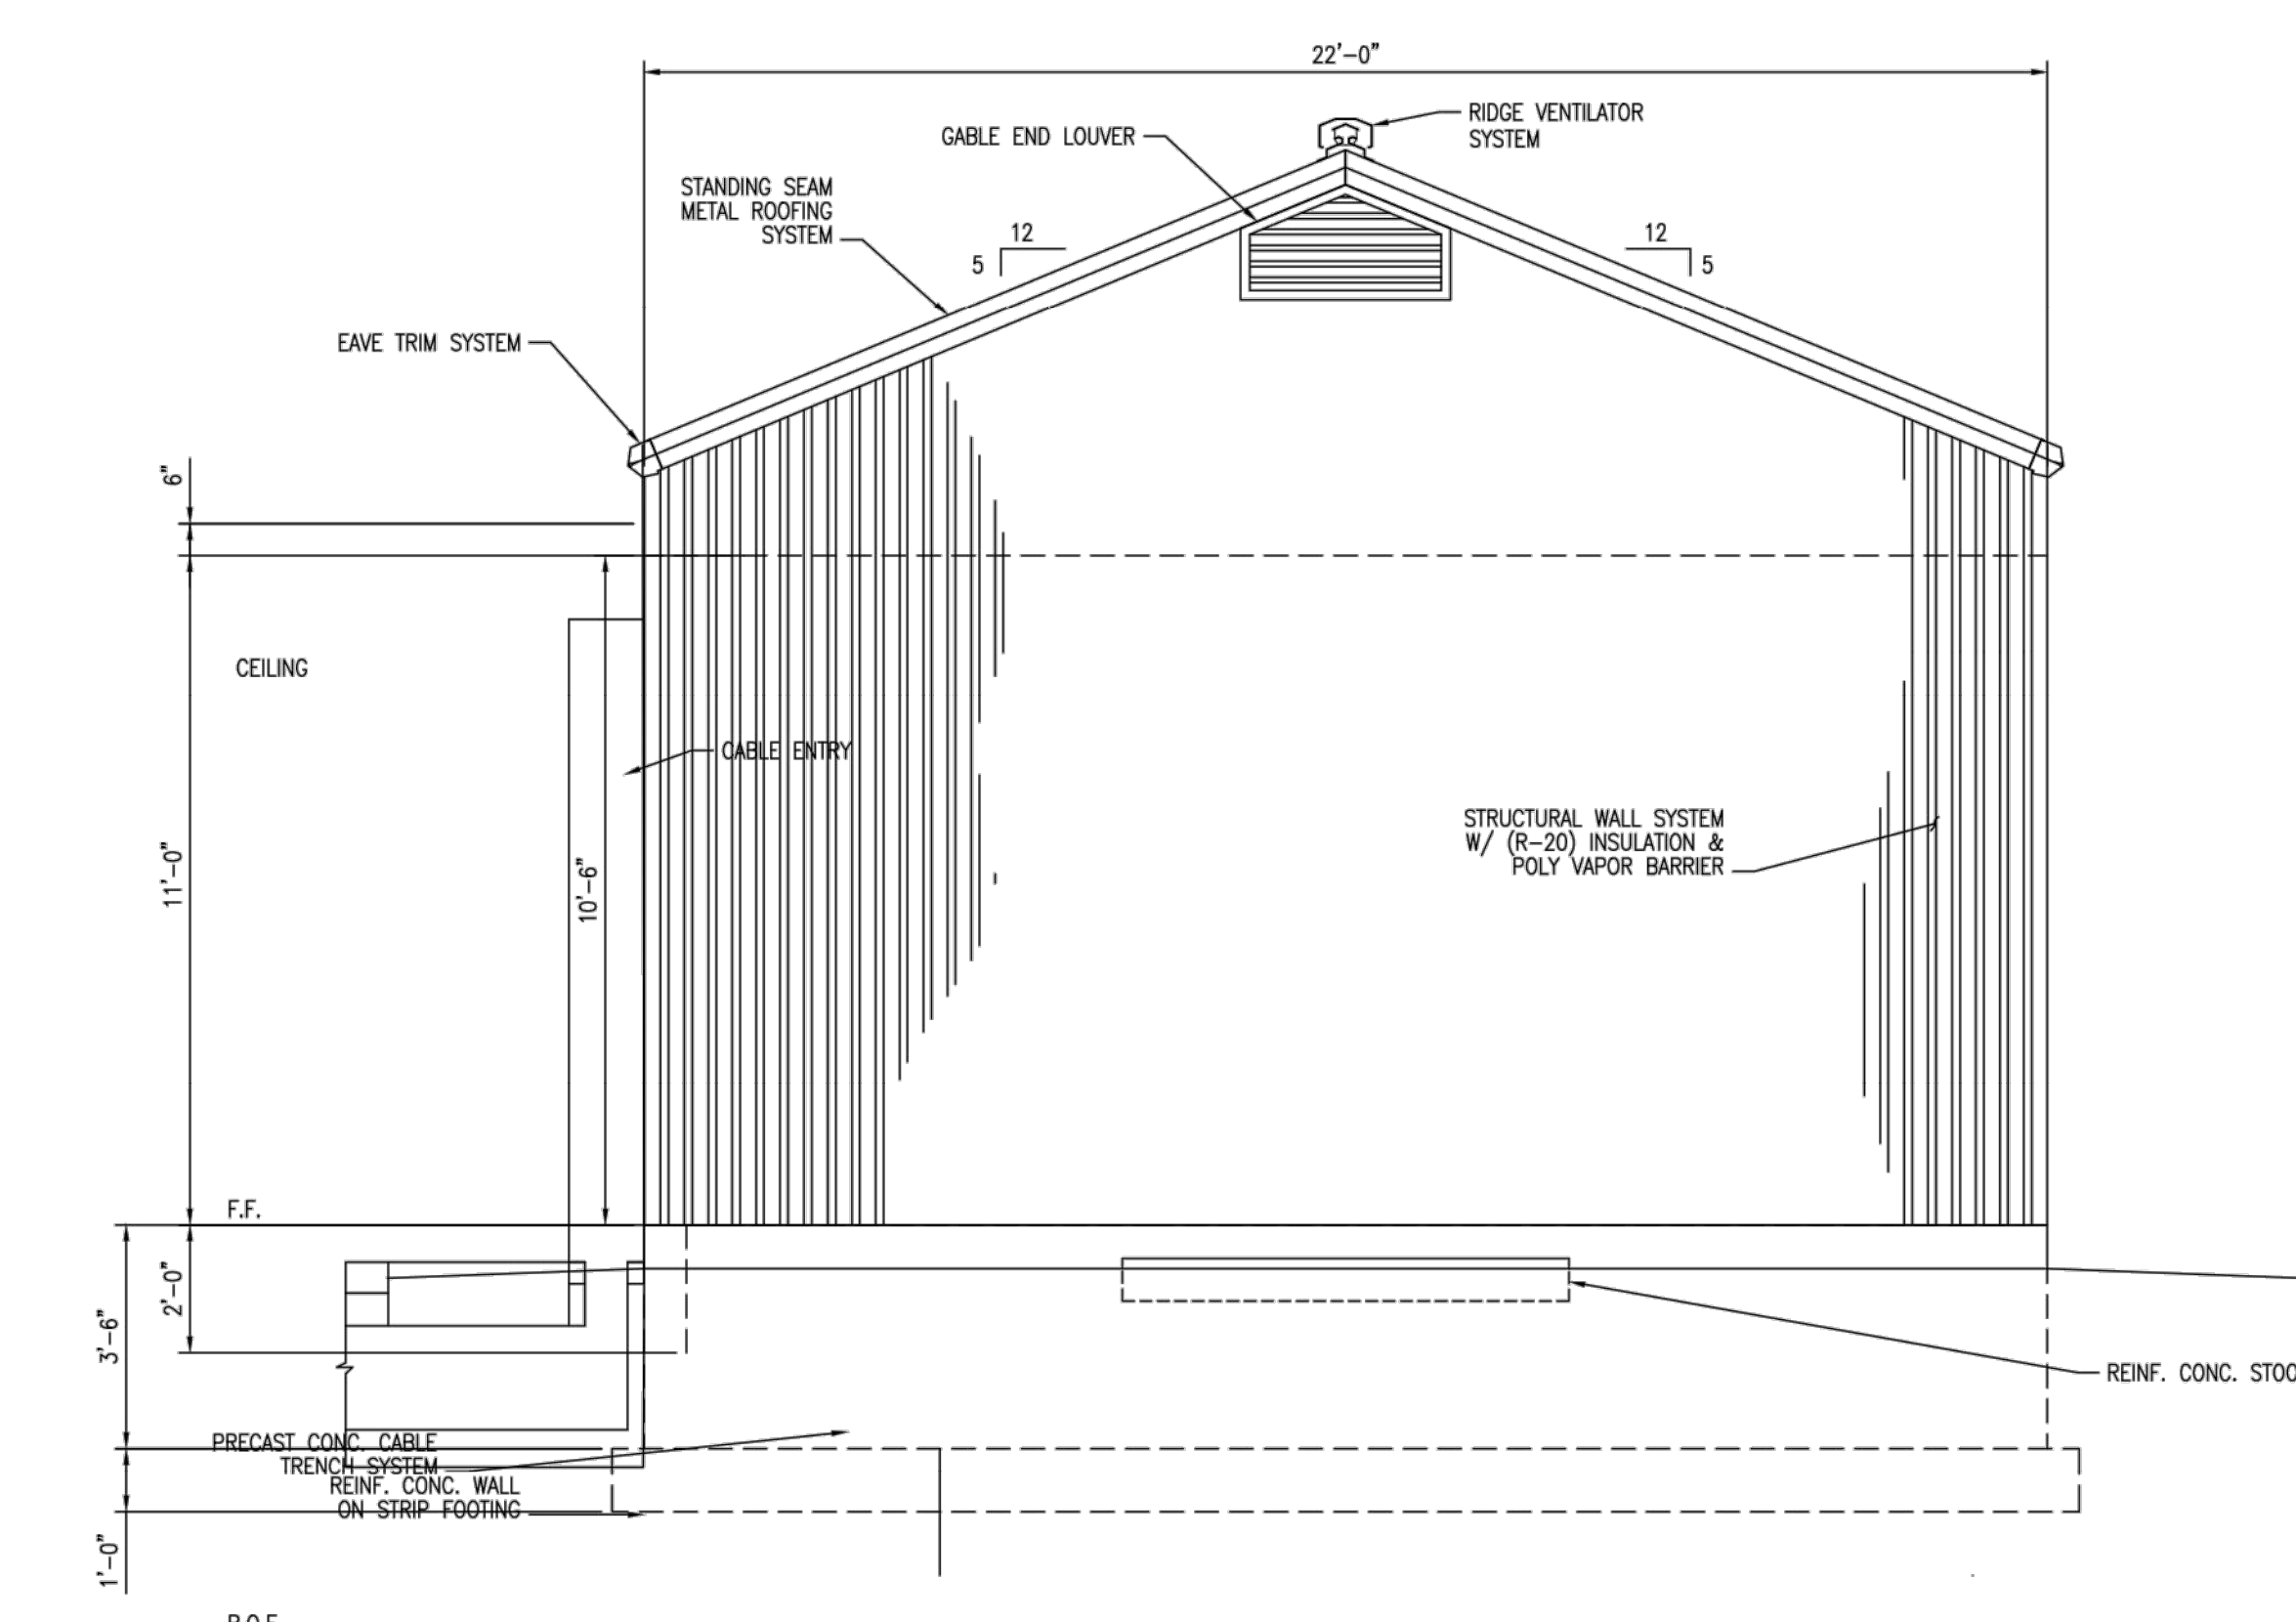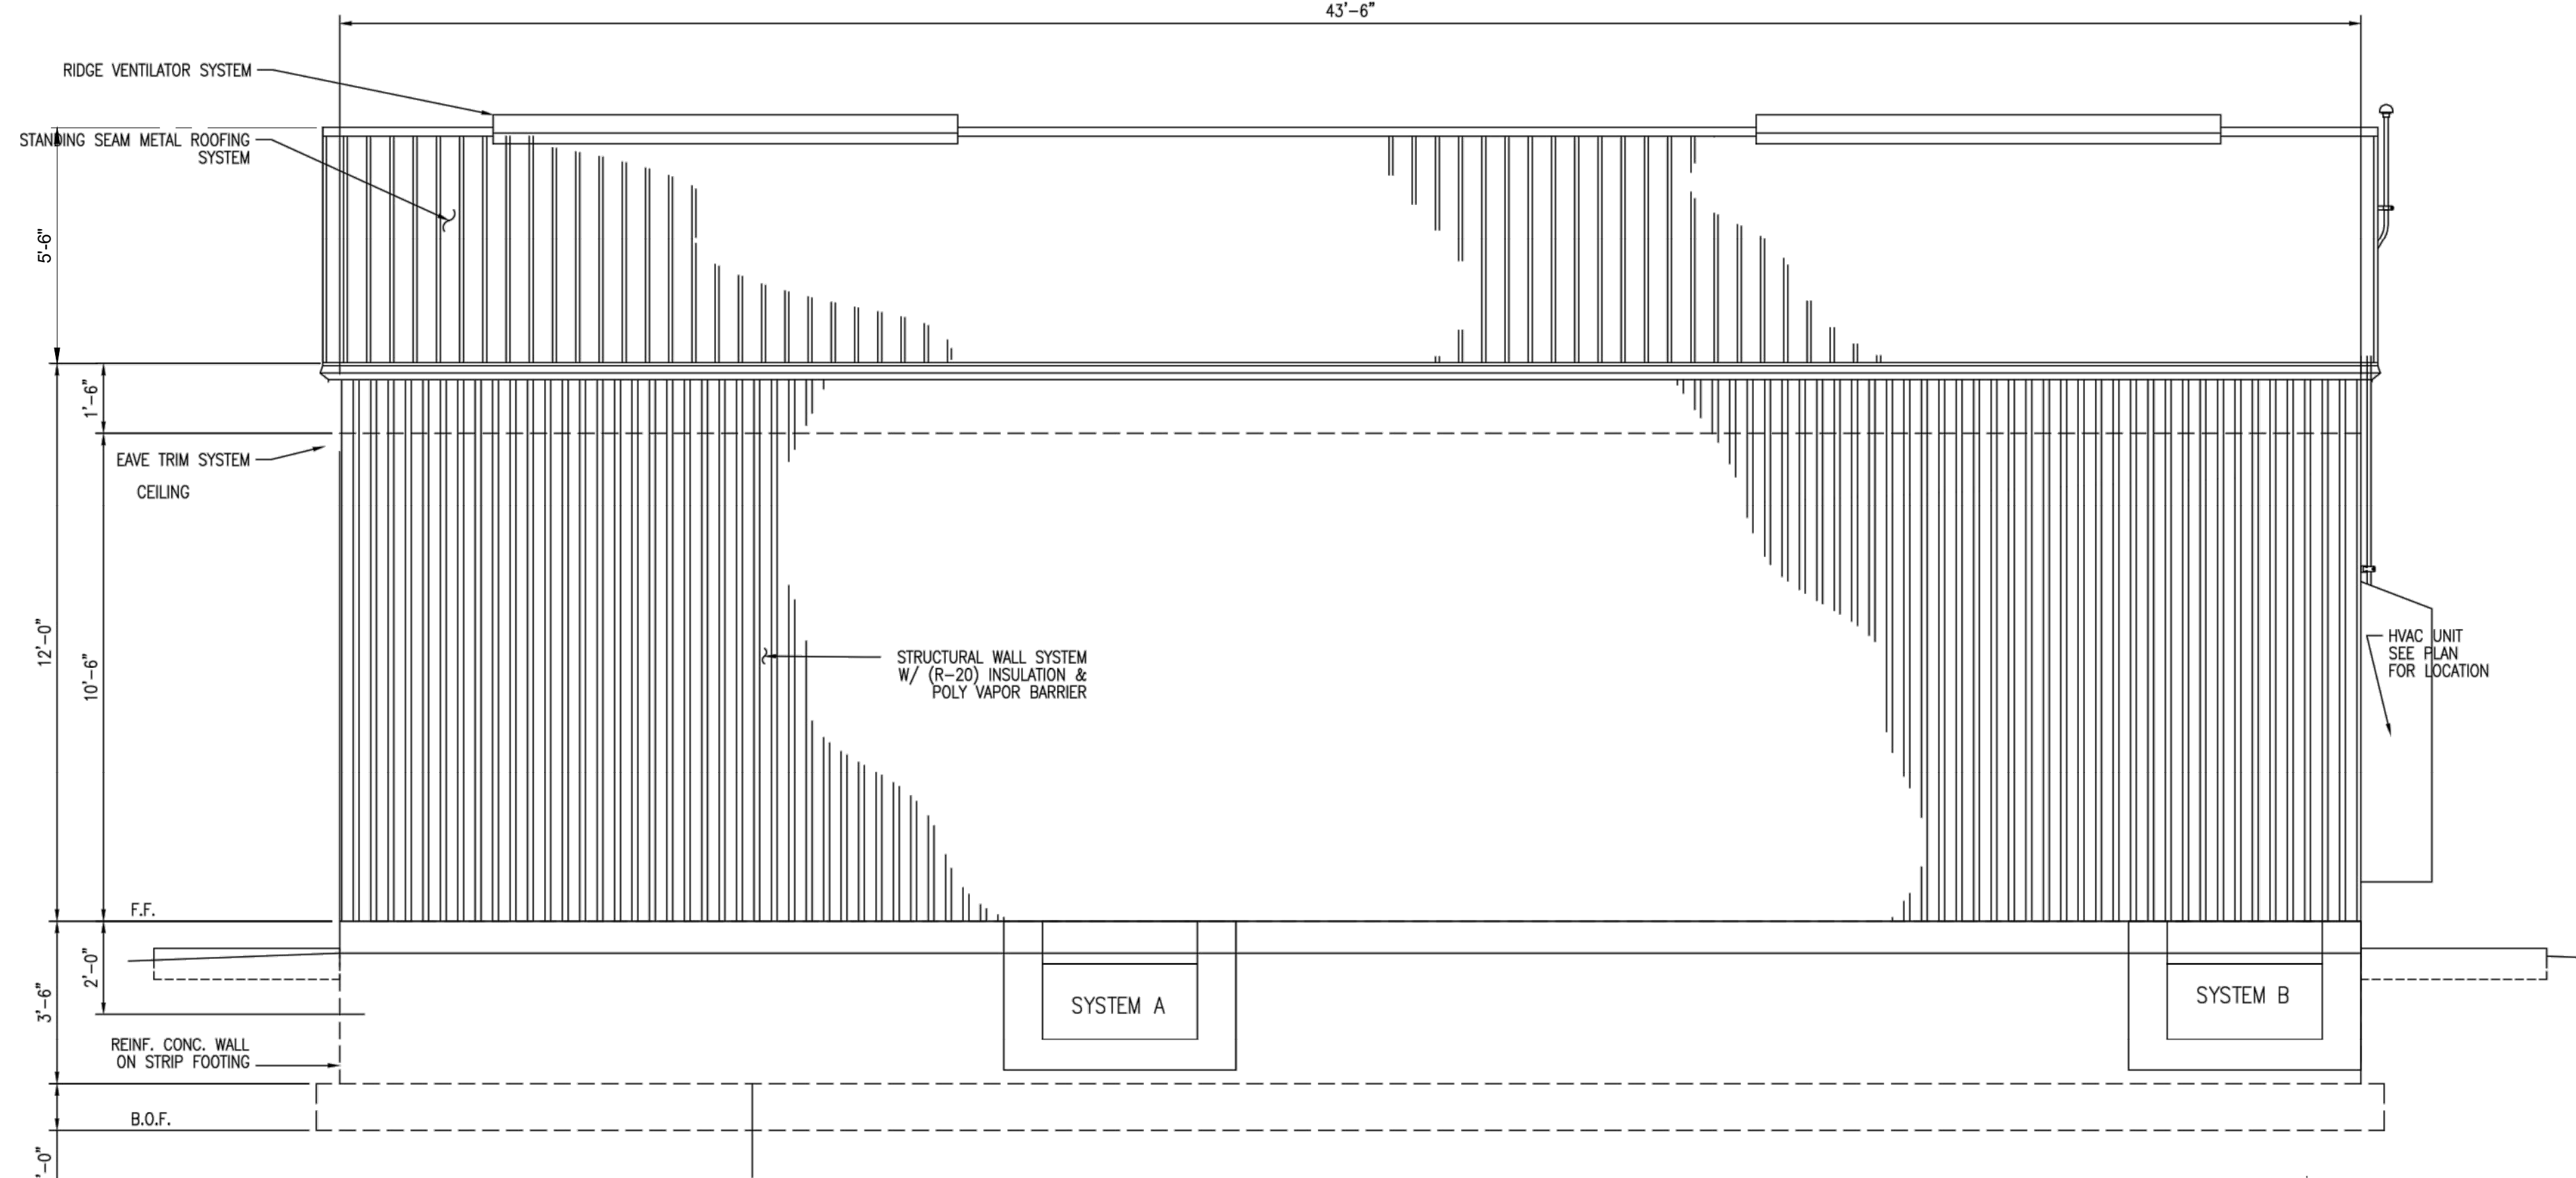

**WEST ELEVATION**  
SCALE: 1/4"=1'-0"

 **NOTE:**  
1. SEE DWG. TM 2.71.08-2 SH3 FOR GENERAL NOTES.  
**REFERENCE DWG'S:**  
TM 2.71.08-2 SH1 FOUNDATION PLAN & SECTIONS  
TM 2.71.08-2 SH3 EXTERIOR BUILDING ELEVATIONS



**PRELIMINARY**  
**NOT FOR CONSTRUCTION**

				<b>CONFIDENTIAL, PROPRIETARY and TRADE SECRET INFORMATION</b> Property of Iberdrola, USA			CONTROL ROOM MEDIUM		
							EXTERIOR BUILDING ELEVATIONS		
				STA#		LOCATION			
				DR. BCH/CCE		DES. AS/CCE		CK. /CCE	APP. -
				SCALE: AS NOTED		APPROVAL DATE: -			
				FILE: TM 2.71.08-2 SH4					
REV. NO. DATE BY				DESCRIPTION		APP. ENGINEERING		REV. 05	
						SUBSTATION		TM 2.71.08-2 SH4	

NO	DATE	REVISIONS AND RECORD OF ISSUE	DRWN	REV'D	APPR	COMP	APPD	KVP	DATE
C	10/19/2020	PRELIMINARY - NOT FOR CONSTRUCTION	NT	KVP	KVP	S&L			
B	06/22/2020	PRELIMINARY - NOT FOR CONSTRUCTION	NT	KVP	KVP	S&L			
A	04/30/2020	PRELIMINARY - NOT FOR CONSTRUCTION	NJM	JTB	KVP	S&L			
SCALE: NONE PREP: NJM    CHKD: JTB APPD: KVP    DATE: 04/01/2020									

CONTRACTOR/INSTALLER SHALL TAKE ALL APPROPRIATE PRECAUTIONS TO ENSURE THE SAFETY OF ALL PEOPLE LOCATED ON THE WORK SITE, INCLUDING CONTRACTOR'S /INSTALLER'S PERSONNEL (OR THAT OF ITS SUB-CONTRACTOR(S)) PERFORMING THE WORK.

ANY MODIFICATION OR ADDITION TO THIS DRAWING BY ANY ORGANIZATION OTHER THAN SARGENT & LUNDY IS NOT THE RESPONSIBILITY OF SARGENT & LUNDY.



NEXTERA ENERGY RESOURCES, LLC  
TRELINA SOLAR ENERGY CENTER, LLC  
115 kV SWITCHYARD  
CONTROL HOUSE PLAN

13666-052-E1-0401